
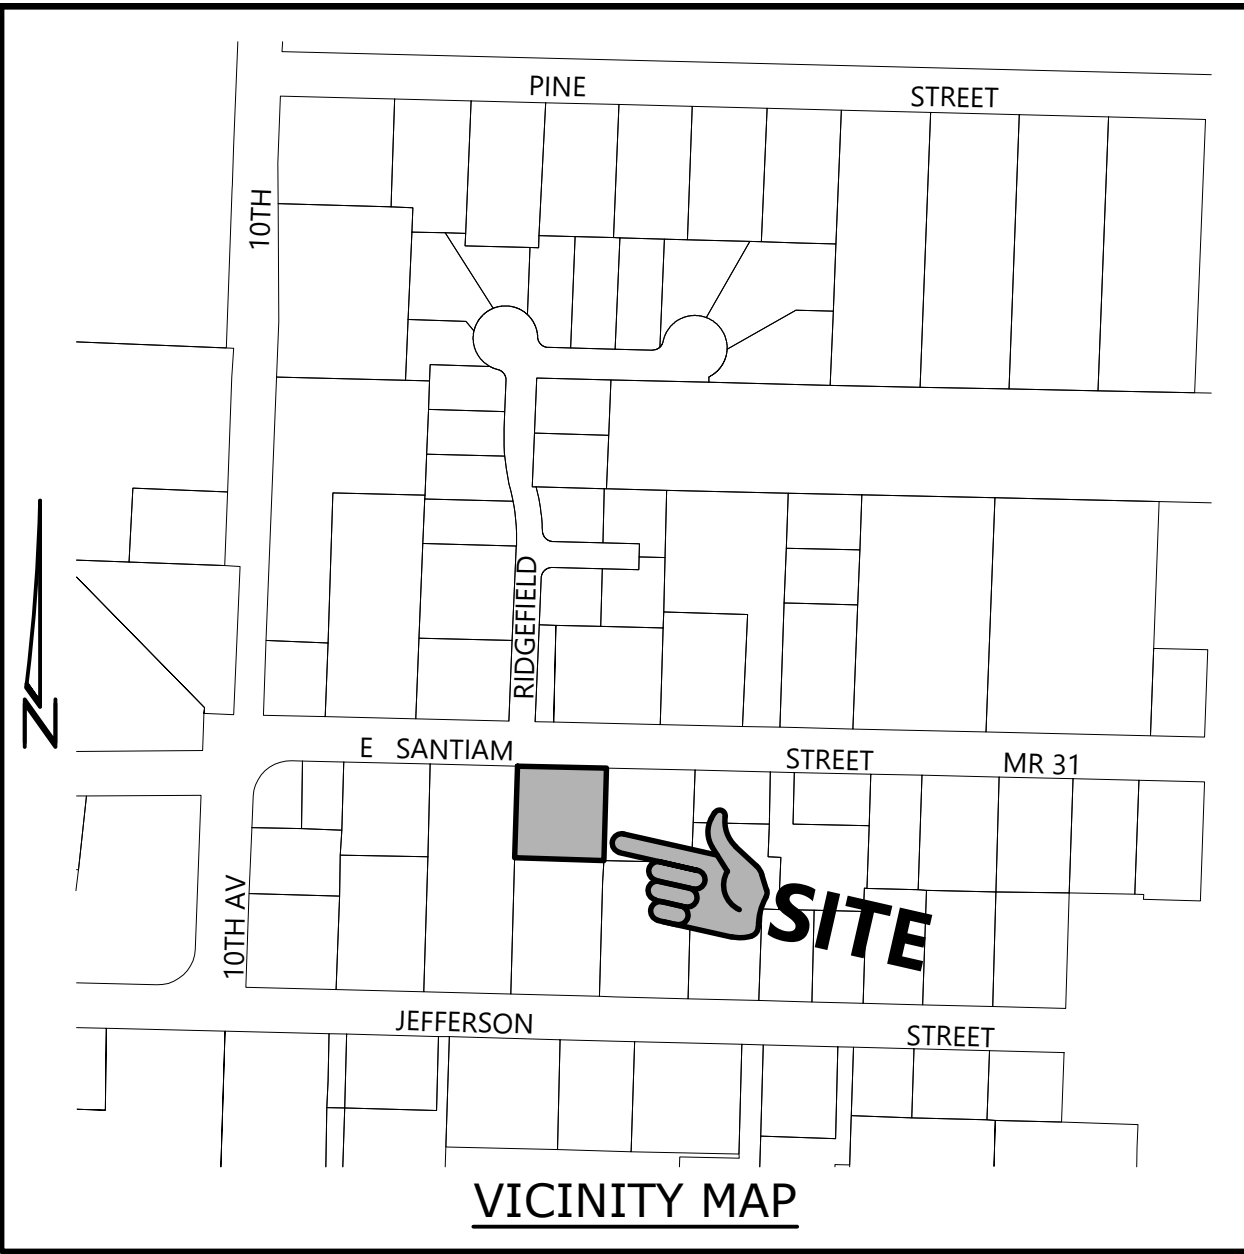
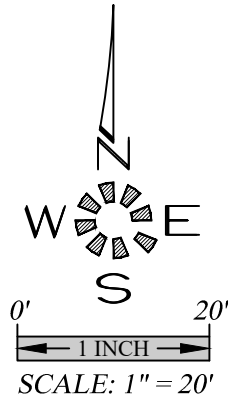


ABBREVIATIONS			
A.C. _____	ASPHALTIC CONCRETE	L _____	LENGTH, LINE
ACMP _____	ALUMINIZED CMP	L.P. _____	LIGHT POLE
ASSY. _____	ASSEMBLY	M _____	METER, MAIN
B.O. _____	BLOW OFF	M.H. _____	MANHOLE
B.F.V. _____	BUTTERFLY VALVE	MTL. _____	METAL
C & G _____	CURB & GUTTER	O.H. _____	OVERHEAD
CATV _____	CABLE TELEVISION	PC _____	POINT OF CURVE
C.B. _____	CATCH BASIN	PCC _____	POINT OF CONTINUING CURVE
C.B.C.O. _____	CATCH BASIN CLEANOUT	PED. _____	PEDESTAL
C.B.I. _____	CATCH BASIN INLET	PRC _____	POINT OF REVERSE CURVE
CCR _____	COMPACTED CRUSHED ROCK	PROP. _____	PROPOSED
C.L. _____	CENTERLINE	PT _____	POINT OF TANGENCY
CMP _____	CORRUGATED METAL PIPE	PUB. _____	PUBLIC
C.O. _____	CLEANOUT	PUE _____	PUBLIC UTILITY EASMT.
CONC. _____	CONCRETE	PVC _____	POLYVINYL CHLORIDE
CONST. _____	CONSTRUCT	PVT. _____	PRIVATE
D.I. _____	DUCTILE IRON	P.P. _____	POWER POLE
DIA. _____	DIAMETER	P.L. _____	PROPERTY LINE
DWG. _____	DRAWING	R _____	RADIUS
EASMT. _____	EASEMENT	R- _____	RIM
E.G. _____	EXIST. GRADE / GROUND	RD _____	ROOF DRAIN
EOP, E.P. _____	EDGE OF PAVEMENT	R.O.W. _____	RIGHT-OF-WAY
ELEC. _____	ELECTRIC	SAN.S. or S.S. _____	SANITARY SEWER
ELEV. or EL. _____	ELEVATION	S _____	SLOPE
EX. or EXIST. _____	EXISTING	S.Q.F. _____	STORMWATER QUALITY FACILITY
F.D.C. _____	FIRE DEPT. CONNECTION	STA. _____	STATION
FT. _____	FEET	STD. _____	STANDARD
F.F. _____	FINISH FLOOR	STL. _____	STEEL
F.G. _____	FINISH GRADE	STM.DRN. or S.D. _____	STORM DRAIN
F.H. _____	FIRE HYDRANT	SVC. _____	SERVICE
F.M. _____	FORCE MAIN	SW _____	SIDEWALK
GUT. or GTR. _____	GUTTER	T.C. _____	TOP OF CURB
G.V. _____	GATE VALVE	TEL. _____	TELEPHONE
IMP. _____	IMPROVEMENT	TYP. _____	TYPICAL
INST. _____	INSERT	U.G. _____	UNDERGROUND
INV. or I- _____	INVERT	VL. _____	VAULT
		W.M. _____	WATER MAIN
SYMBOLS			
EX. _____	PROP. _____	EX. _____	PROP. _____
⊙	● BLOW OFF ASSY.	⑤	⑤ MANHOLE SAN. SEWER
▤	▤ CATCH BASIN	⑥	⑥ MANHOLE STORM DRAIN
▨	▨ CATCH BASIN CLEANOUT	②	② 2' DIA. C.O. / M.H.
▣	▣ CATCH BASIN INLET	①	① MANHOLE TELEPHONE
△	▲ CATV PED. / BOX	Ⓜ	Ⓜ MANHOLE WATER
○	● CLEANOUT	▷	▷ REDUCER / INCREASER
⊠	⊠ ELEC. PED. / BOX	⊠	⊠ TEL. PED. / BOX
⊙	● FIRE HYDRANT	⊠	⊠ TRAFFIC PED. / BOX
⊙	● GAS LOCATION MARKER	⊙	⊙ UTILITY / POWER POLE
⊗	⊗ GAS VALVE	□	■ WATER METER
⊠	⊠ MAIL BOX	⊗	⊗ WATER VALVE
---	--- CABLE TELEVISION	---	--- SANITARY SEWER EXIST.
---	--- CENTERLINE	---	--- SANITARY SEWER CONST.
---	--- DITCH C.L.	---	--- STORM DRAIN EXIST.
---	--- ELECTRICAL LINE	---	--- STORM DRAIN CONST.
---	--- GAS MAIN	---	--- WATER MAIN EXIST.
---	--- TELEPHONE LINE	---	--- WATER MAIN CONST.

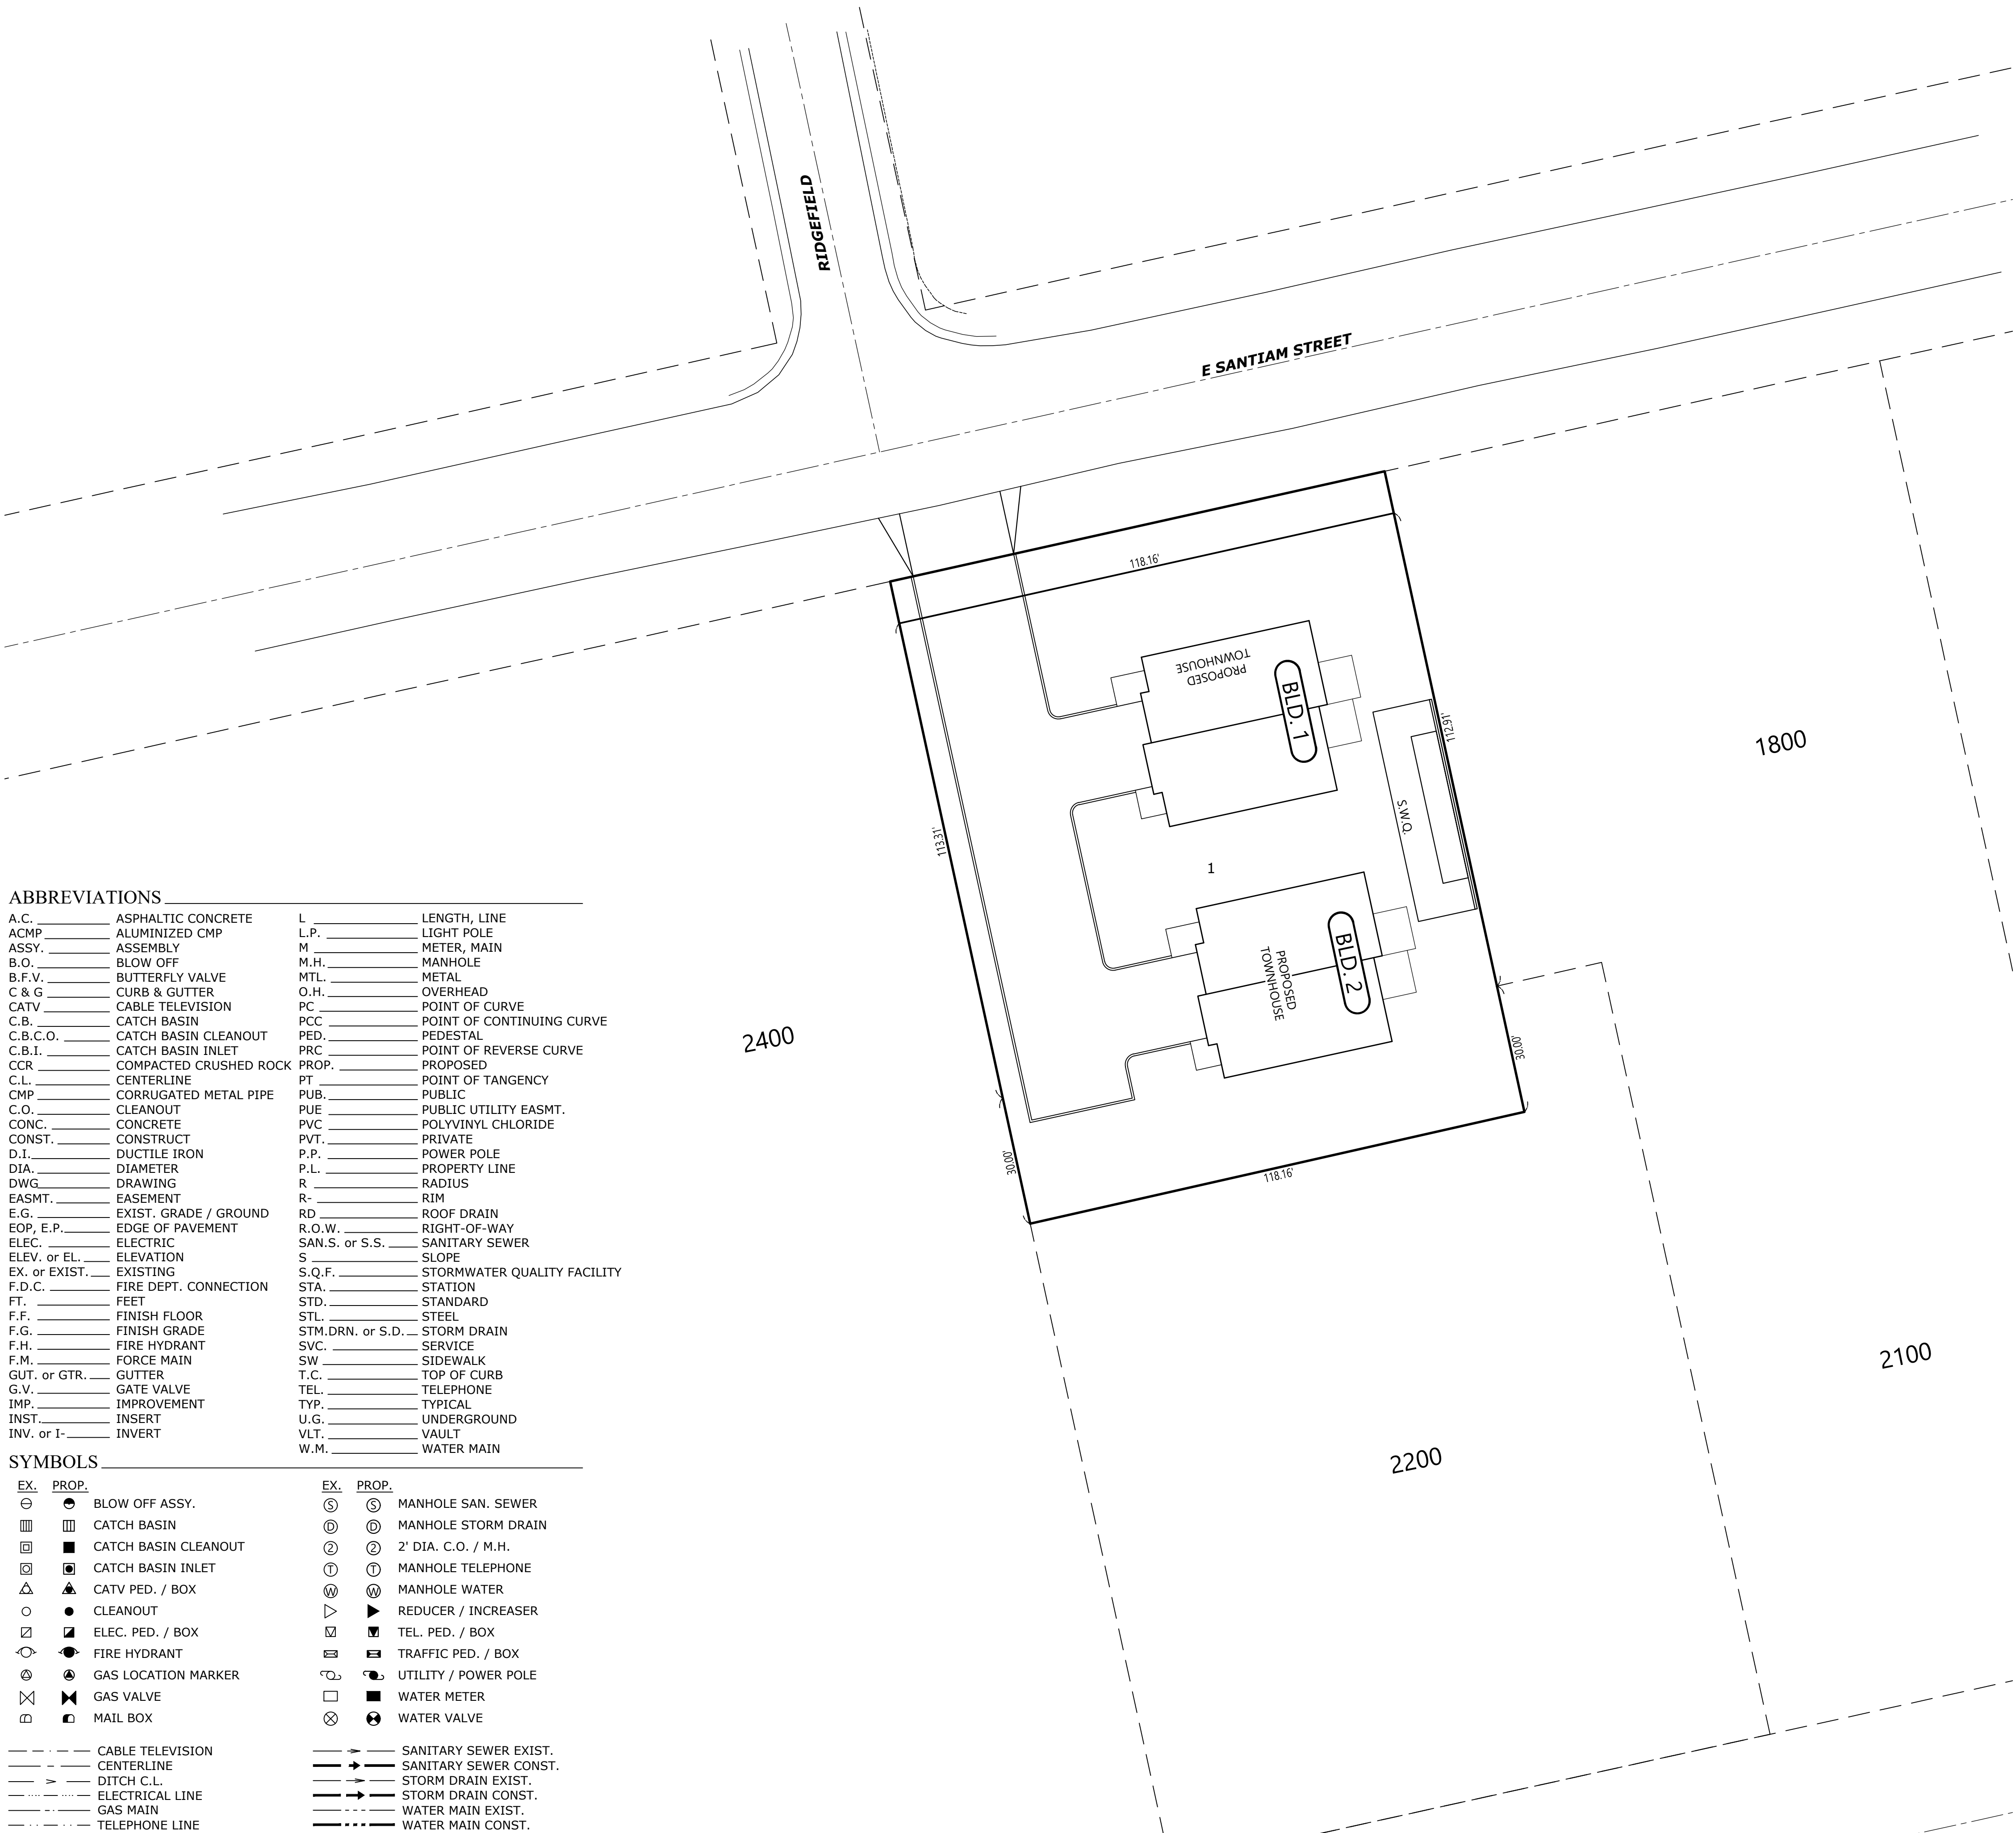

T.B.M. 467.36
PK LOCATED ON NORTH SIDE OF EAST
SANTIAM STREET. NGVD29 DATUM.

SANTIAM STREET DEVELOPMENT

SEC. 11, T. 8 S., R. 1 W., W.M.
CITY OF STAYTON
MARION COUNTY, OREGON

Owner / Developer:
SLY TORAN
12309 MILLER ROAD
GERVAIS, OREGON 97026

SHEET INDEX

SDR1	COVER SHEET
SDR2	EXISTING CONDITIONS PLAN
SDR3	SITE PLAN
SDR4	OPEN SPACE PLAN
SDR5	GRADING PLAN
SDR6	PRIVATE STORM DRAIN PLAN
SDR7	PRIVATE SANITARY SEWER PLAN
SDR8	PRIVATE DOMESTIC WATER PLAN

L0.0	LANDSCAPE COVER SHEET
L1.1	SCHEMATIC LANDSCAPE PLAN



COVER SHEET

SANTIAM STREET
DEVELOPMENT

NO CHANGES, MODIFICATIONS
OR REPRODUCTIONS TO BE
MADE TO THESE DRAWINGS
WITHOUT WRITTEN
AUTHORIZATION FROM THE
DESIGN ENGINEER.
DIMENSIONS & NOTES TAKE
PRECEDENCE OVER
GRAPHICAL REPRESENTATION.

Design: M.D.G.
Drawn: C.F.G. & M.K.D.
Checked: B.M.G.
Issue Date: 11/6/23
Scale: AS SHOWN



EXPIRES: 06-30-2025

JOB # 7662

SDR1